




OPTCL TRANSIT HOUSE
(GRID STANDARDIZATION)

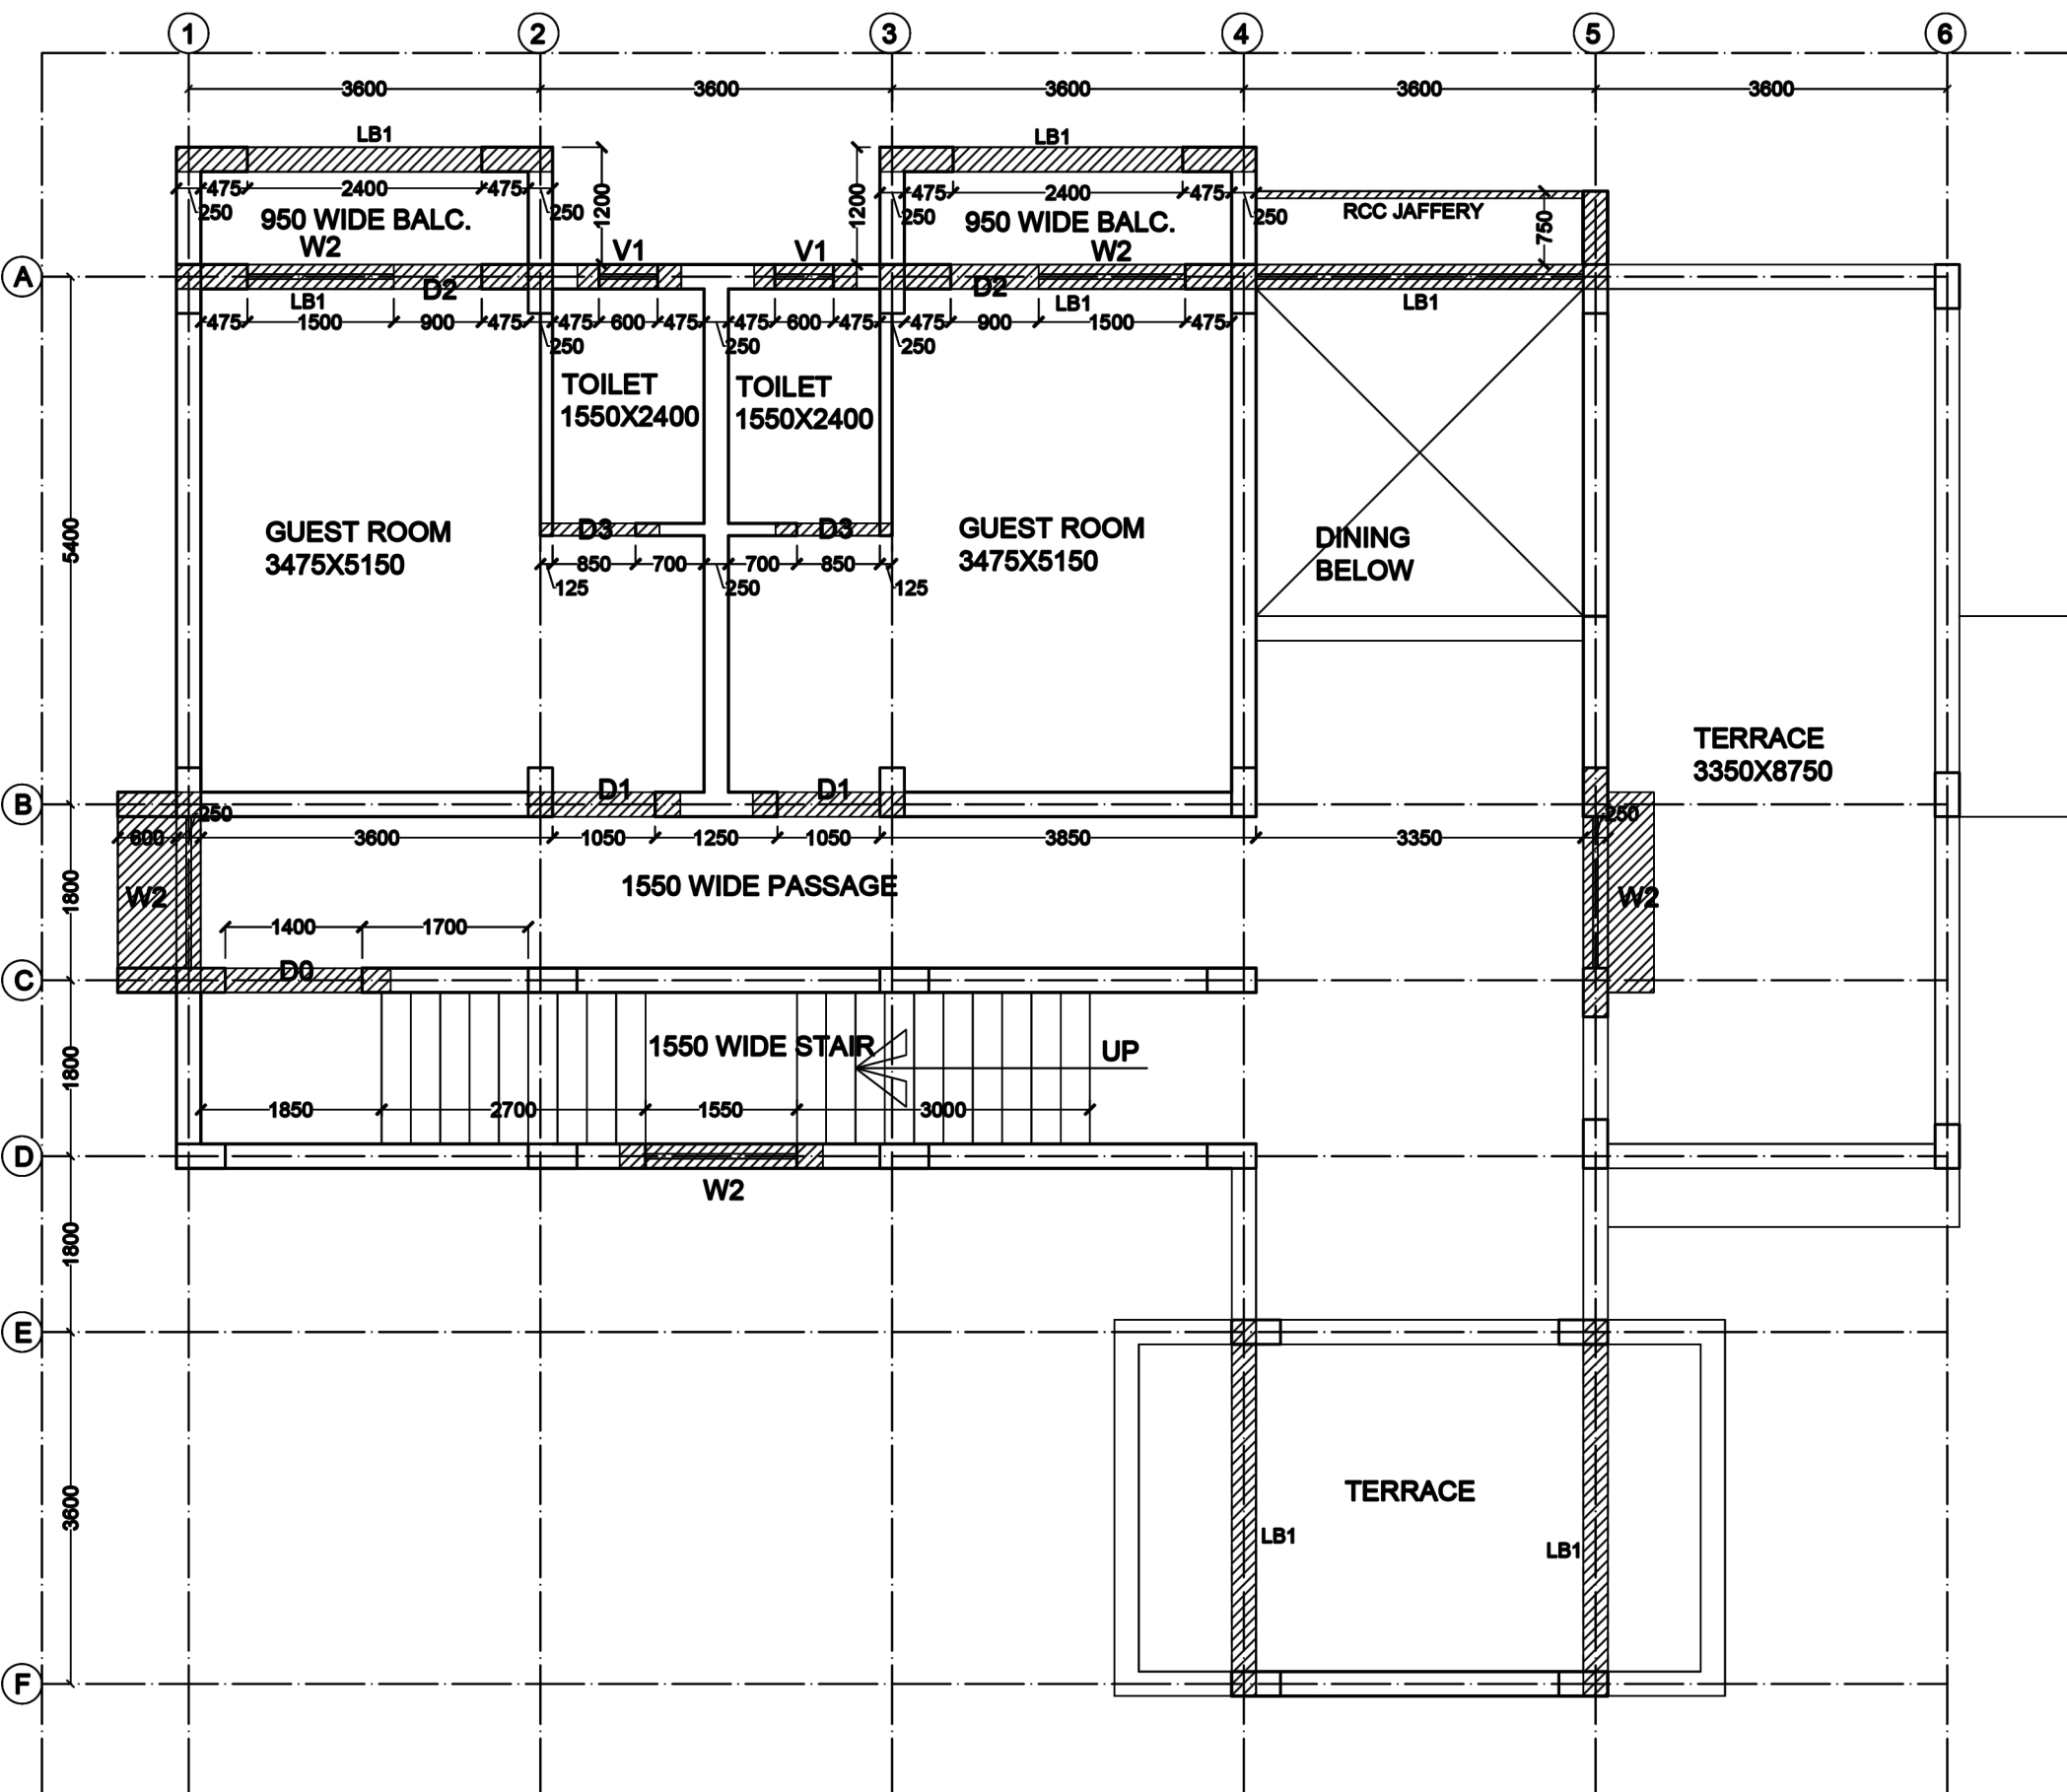


FIRST FLOOR PLAN (LINTEL LEVEL)

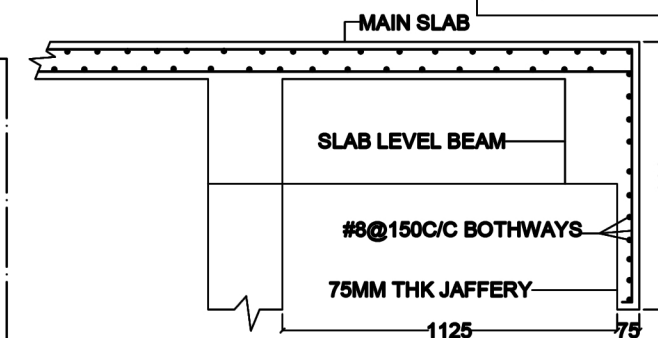


DETAIL OF RCC JAFFERY

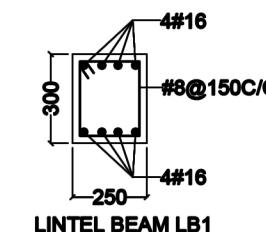


LINTEL BEAM LB1

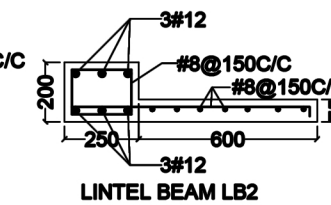

LINTEL BEAM LB2

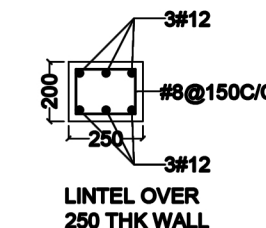

LINTEL OVER
250 THK WALL

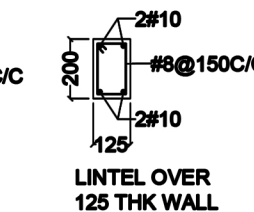

LINTEL OVER
125 THK WALL

SCHEDULE OF OPENINGS

D0	1400X2400	DOOR
D1	1050X2400	DOOR
D2	900X2400	DOOR
D3	850X2400	DOOR
W0	3350X1650	WINDOW
W1	2400X1650	WINDOW
W2	1500X1650	WINDOW
W3	600X1650	WINDOW
V1	600X800	VENTILATOR

CLIENT -

GOVERNMENT OF ODISHA

IMPLEMENTING AGENCY -

OPTCL, ODISHA

BUILDING TYPE / WORK -

TRANSIT HOUSE : (G + 2)

DRAWING TITLE -

FIRST FLOOR PLAN
(LINTEL LEVEL)

DRAWING NUMBER -

ST-11

SCALE -

DESIGNED BY -

DATE -

Architects -

SPACE ARCH
ARCHITECTS-ENGINEER-PLANNER
205, JAYADEV VIHAR, BHUBANESWAR



AR. D.K. PARIDA
REGD NO. GA94/17280

14.03.2022
Professor
Civil Engineering Department
IGIT Sarang, Odisha